

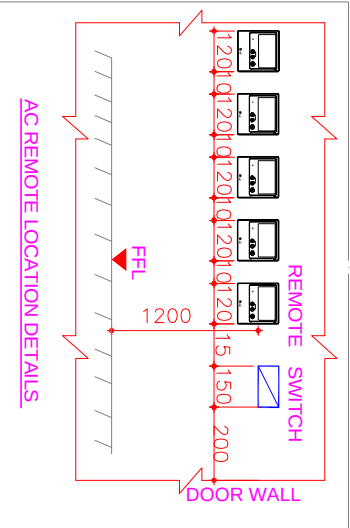


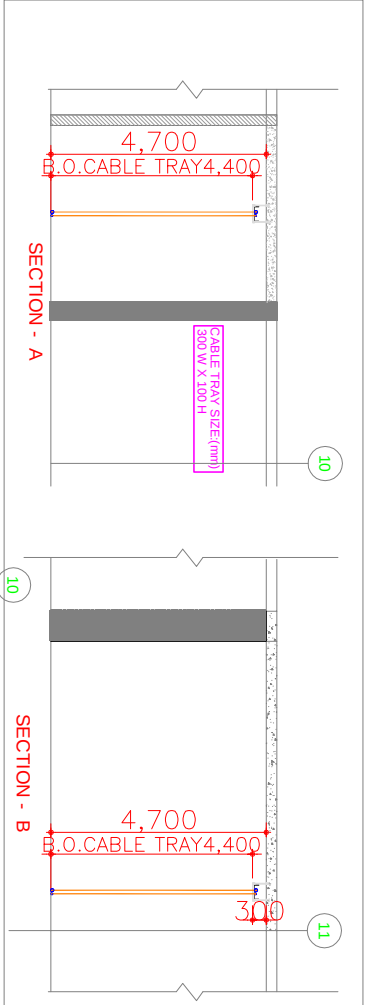

HVAC LEGEND

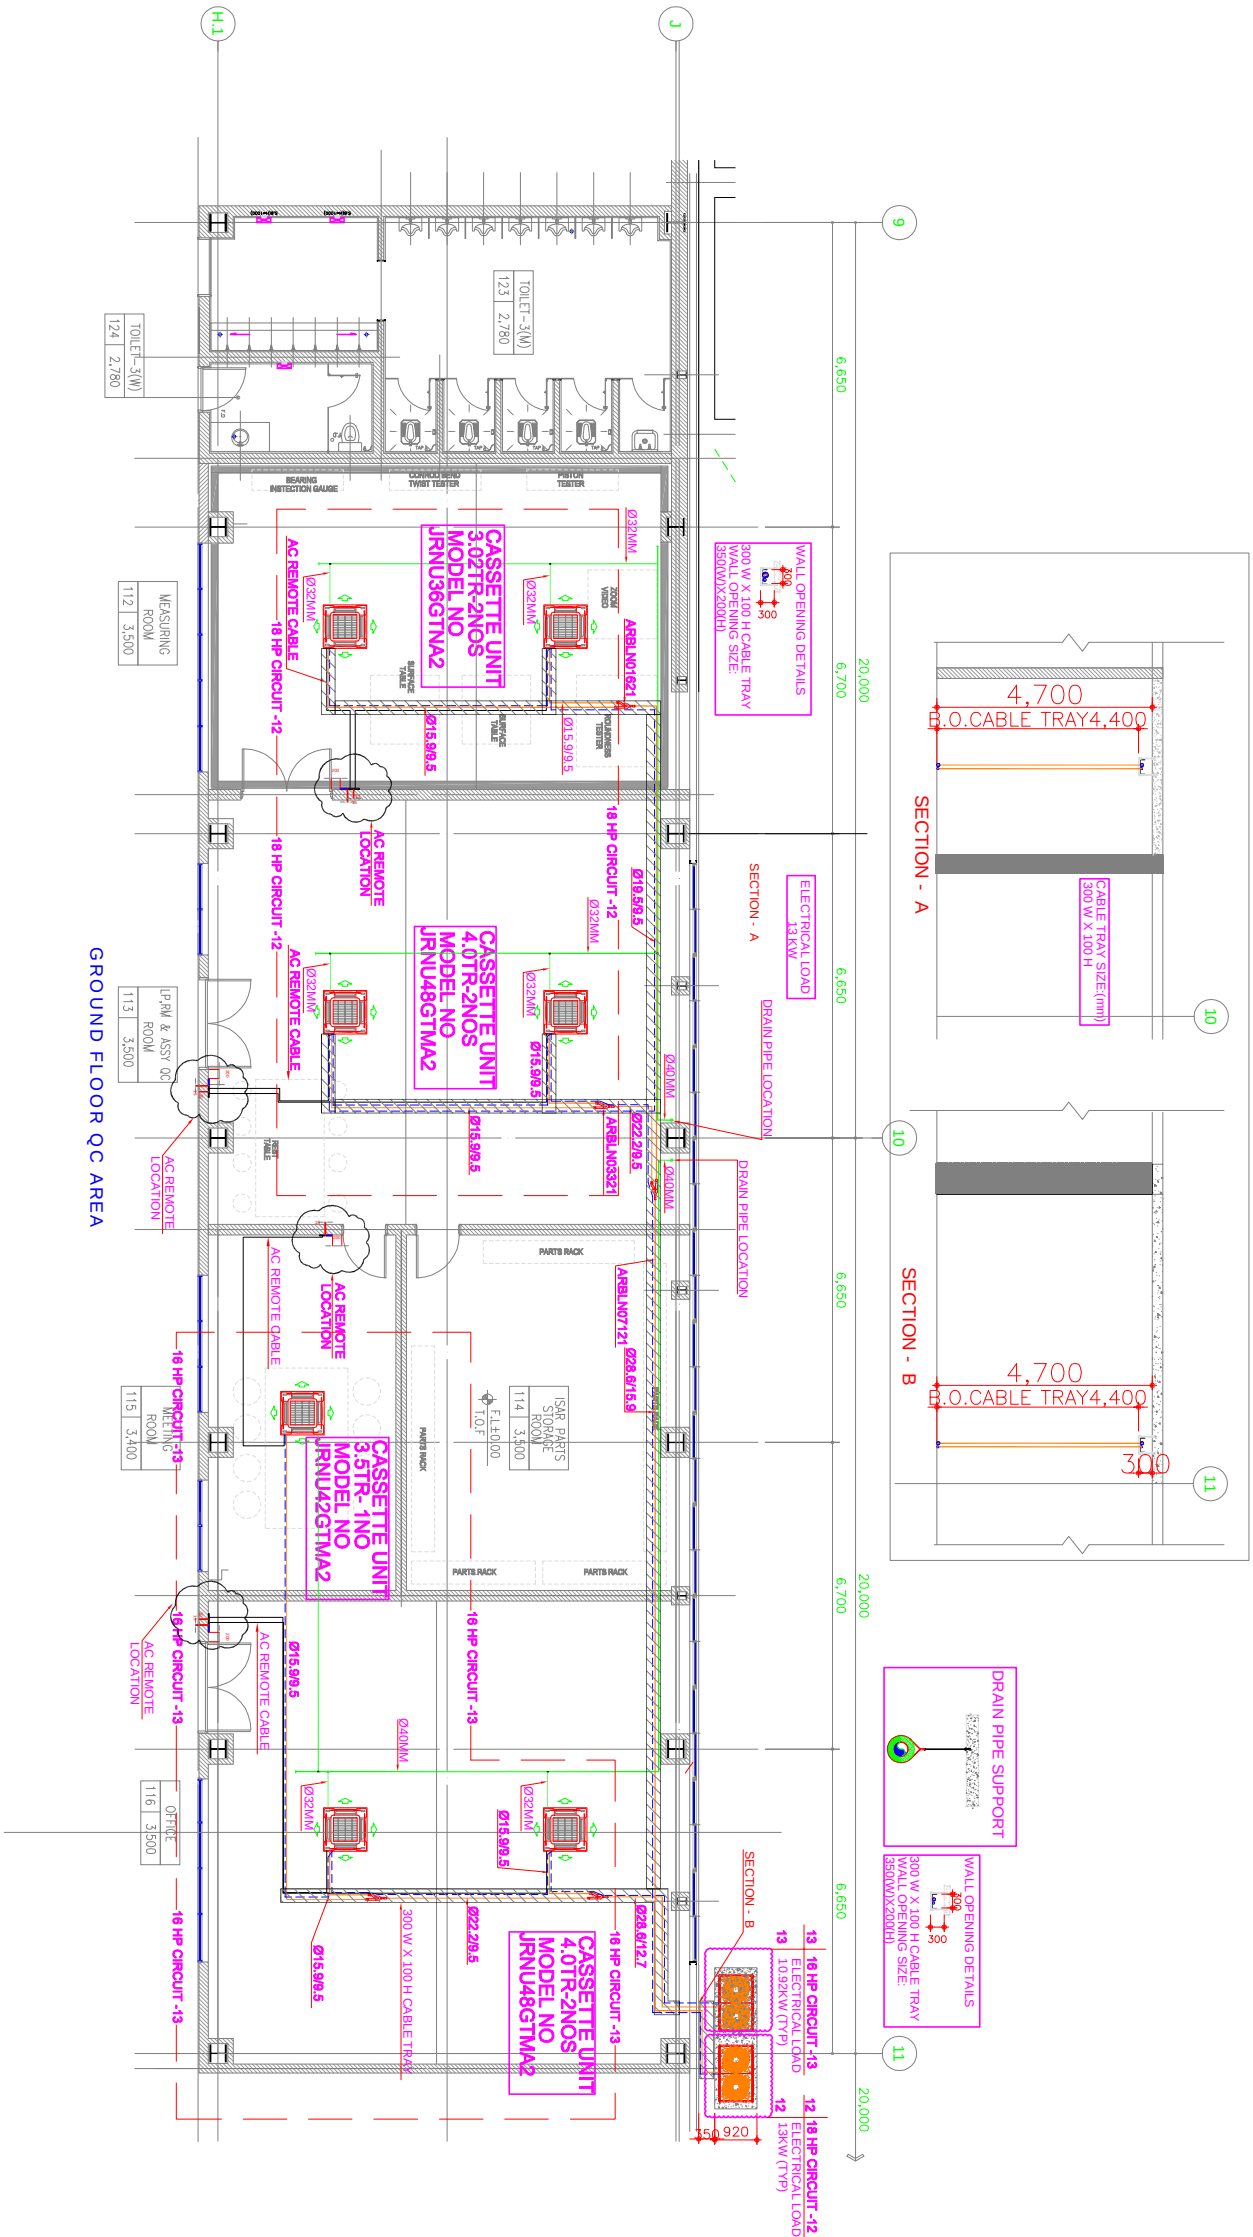

CASSETTE UNIT

REF PIPE

DRAIN PIPE

Y - JOINTS

VRF ODU

COMMUNICATION CABLE

REMOTE CABLE

SUB CONTRACTOR :

SAMHO GUNYOUNG
CONSTRUCTION PVT. LTD.,

CLIENT

HYUNDAI MOTOR INDIA LTD.

PROJECT LOCATION

HMI ENGINE SHOP
PHASE3 PROJECT

MAIN CONTRACTOR

HYUNDAI
ASSET MANAGEMENT CO., LTD.
231, Yangjeong 2-dong, Seochogu, Seoul, Korea
TEL: 82-2-3464-6901 FAX: 82-2-3464-6901
HOMEPAGE : www.amco.co.kr E-MAIL : amco@amco.co.kr

HVAC CONTRACTOR:

LG ELECTRONICS INDIA PVT LTD
AA, 11, 2nd Avenue, Fathima Towers,
Anna Nagar, Chennai - 600040
Tel: 044-65510501 - 504, Fax: 044-26203506

TITLE:
VRF SYSTEM LAYOUT & INDOOR
UNITS LOCATION FOR QC AREA

DEALER

METRO AIRCONN
10/1, SUBURBAN AVENUE, P. RAMASAMY ROAD,
ALWARPET, CHENNAI - 18
PHONE: 45511511
TOTAL AIR-CONDITIONING SOLUTIONS E-MAIL:- design@metroairconn.com

REV.	DATE	DESCRIPTION	DRN.	CHKD.
1.	08-02-2013	AS BUILD AC LAYOUT	ALEX	GUHA

DRG No.	DATE	SCALE	CHKD.	PAPER SIZE
HYUNDAI/LG/01	08.02.2013	AS NOTED	GUHA	